
 


THIS DRAWING IS THE PROPERTY OF 4D ENGINEERING, LLC, AND SHALL NOT BE REPRODUCED OR COPIED IN WHOLE OR IN PART. IT IS ONLY TO BE USED FOR THE ACTUAL PROJECTS THE DRAWING.

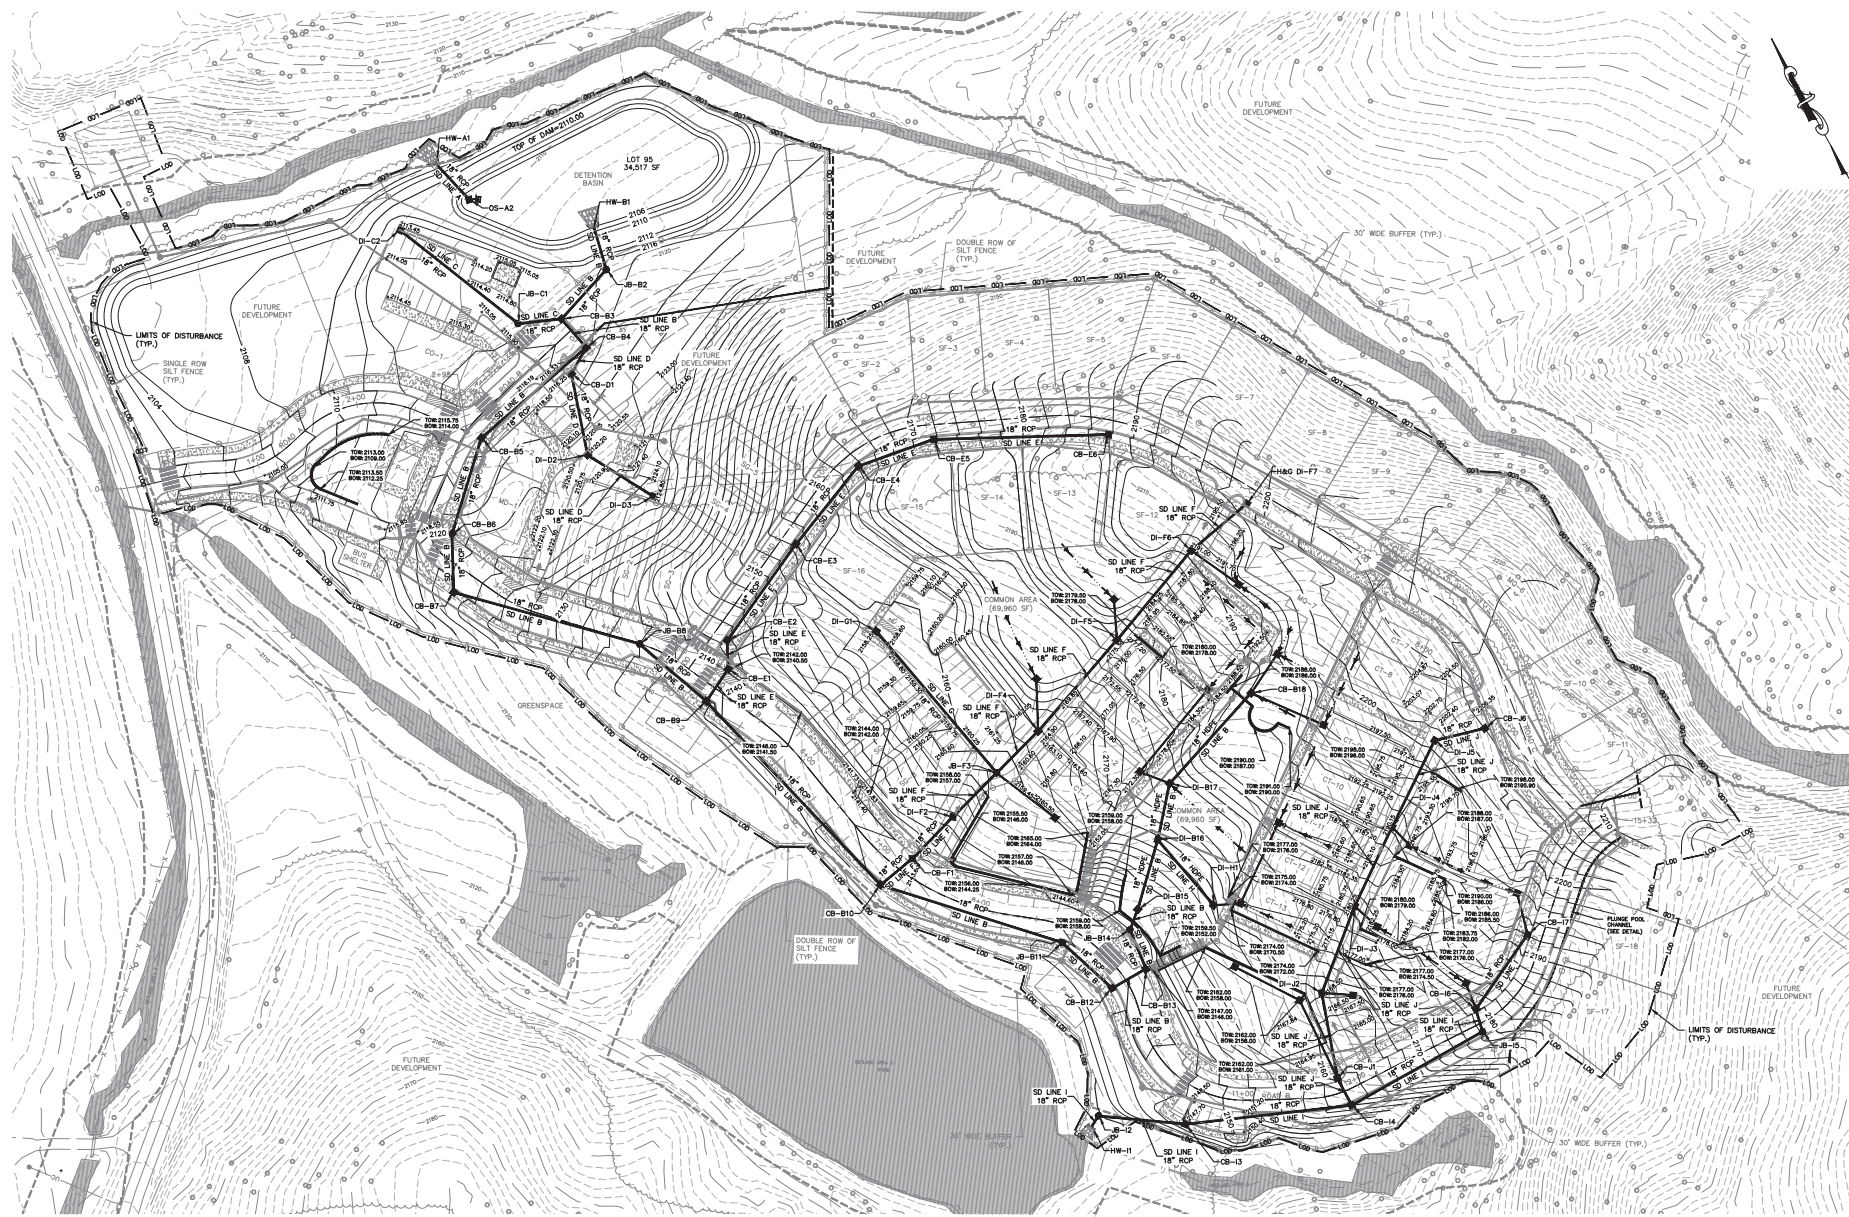

3 DAYS BEFORE DIGGING IN
NORTH CAROLINA
CALL 1-800-632-4949
North Carolina 611



4D
ENGINEERING
"SUPERIOR COMPREHENSIVE
ENGINEERING SOLUTIONS"
WWW.4DENGR.COM
CIVIL ENGINEERING

NORTH CAROLINA
REGISTERED PROFESSIONAL ENGINEER
4D ENGINEERING GROUP, PLLC
P-1249

NORTH CAROLINA
REGISTERED PROFESSIONAL ENGINEER
4D ENGINEERING GROUP, PLLC
P-1249

REVISIONS		
#	DESCRIPTION	DATE

SHEET

GRADING & DRAINAGE PLAN

PROJECT

CAMP CREEK PHASE 1
IN
WHITTIER, NC

SCALE: 1"=50'

PROJ NO: 19042

C9

JULY 29, 2021